


Meeting Area

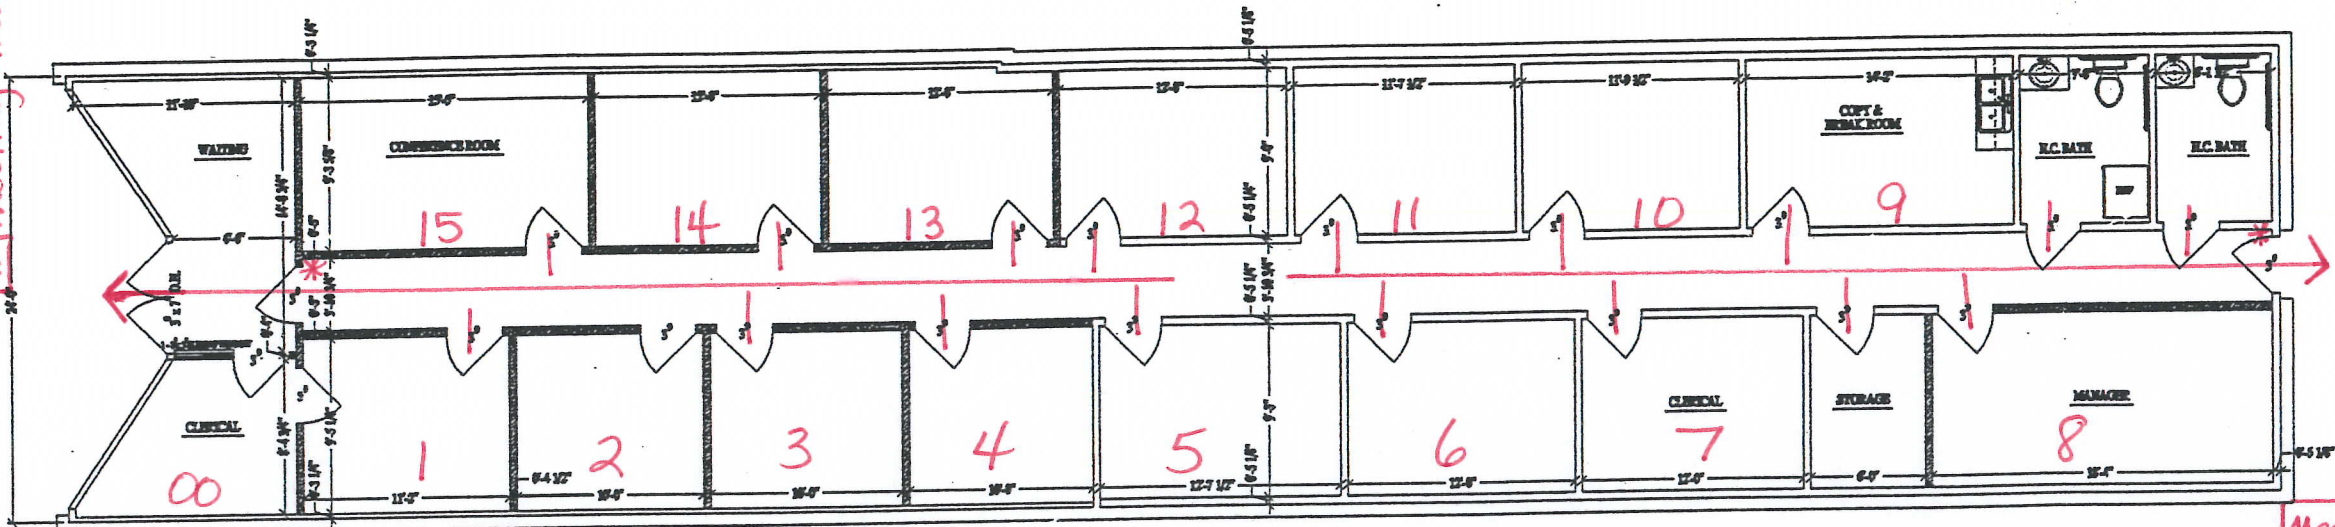

* Fire Extinguisher
H- Hydrant

FLOOR PLAN
SCALE: 1/4" = 1'-0"

Meeting Area

PARKING